

8TH FLOOR PLAN  
SCALE: 1:50

ELECTRICAL / DATA / VOICE LEGEND	
<b>GENERAL NOTES</b>	
1.	CONTRACTOR TO INSPECT SITE
2.	ALL PLUG SOCKETS TO BE VETI 2 WHITE
3.	ALL LIGHTING SWITCHES TO BE 150mm AFFL
4.	ALL AC POWER TO SPECIALIST DETAILS
ALL PLUG POINTS TO BE 300MM AFFL UNLESS OTHERWISE INDICATED	
ALL LIGHTING SWITCHES, AC CONTROLLERS AND TAG READERS TO BE 1100 MM AFFL TO COUNTER POINT	
ALL SWITCHES: PLUGS: TELEPHONE & DATA OUTLETS AS PER COLOUR INDICATION	
<b>POWER &amp; DATA</b>	
	CLEAN LINE SWITCHED SOCKET OUTLET
	NORMAL SWITCHED SOCKET OUTLET
	DATA OUTLET
	BLANK BOX WITH COVER PLATE
	FLOOR BOX: VARIOUS CONFIGURATIONS INDICATED ON DRAWING
	D4 GRID • 2x OLD RSA (CLEAN) • 2x OLD RSA
	POWER SKIRTING TO BE 1x COMPARTMENT
	NEW LIGHT SWITCH
	NEW 2WAY LIGHT MASTER SWITCH
	NEW DIMMER LIGHT SWITCH
	NEW DOT UNIT: • 1x OLD RSA • 1x USB-A • 1x USB-C • 1x NEW RSA



01 VETI 2 - 1x OLD RSA WITH SWITCH



02 VETI 2 - 2x OLD RSA & 2x NEW RSA



03 VETI 2 - 2x OLD RSA WITH SWITCH



04 VETI 2 - 2x USB, 2x NEW RSA, 1 OLD RSA



05 VETI 2 - 1x ISOLATOR SWITCH




06 VETI 2 - 1x DATA POINT



07 VETI 2 - 1x DEDICATED OLD RSA WITH SWITCH



08 D4 - DOT EVO WHITE

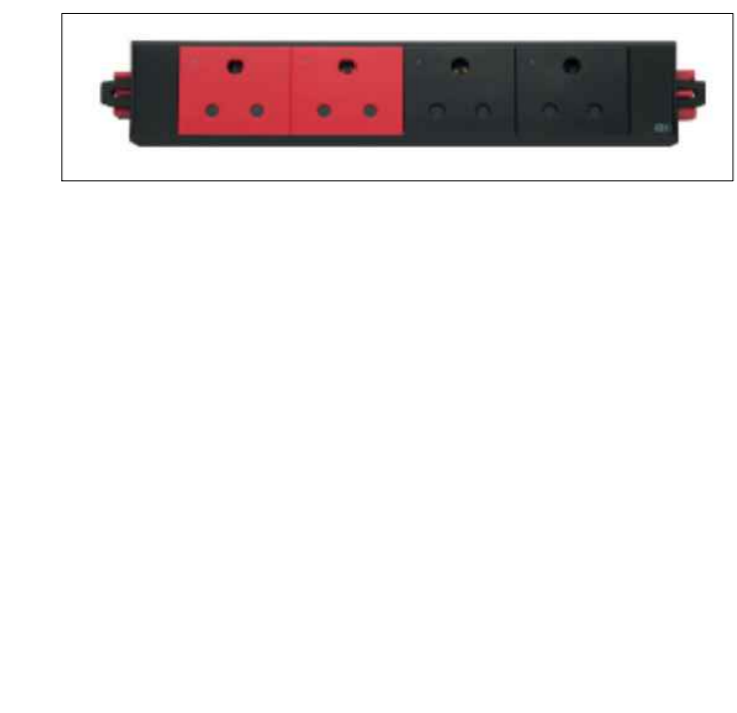

09 D4 - GRID ECO RANGE TYPE 9

revision	description	date
C	INFORMATION ISSUE	2024-01-31
B	INFORMATION ISSUE	2023-12-14
A	COSTING ISSUE	2023-12-07

COLLABORATION

First Floor, Sandton House, 179 Balthazar Street, Cape Town  
Tel: 021 446 8896

ELECTRICAL LAYOUT

WESGRO  
80TH FLOOR  
MEDIA 24 BUILDING  
ERF 244  
40 HEERENGRACHT STREET, CAPE TOWN

scale	date	drawn	chkd
1:100 @ A0	2024-01-31	DS	DS
drawing number	revision		
PI1982/08/R/40	C		